


The information contained in this drawing is the property of the Client and is to be used only for the purposes for which it is intended. It is not to be used for any other purpose without the written consent of the Engineer. The Engineer shall not be responsible for any loss or damage arising from the use of this drawing for any purpose other than that for which it was prepared.

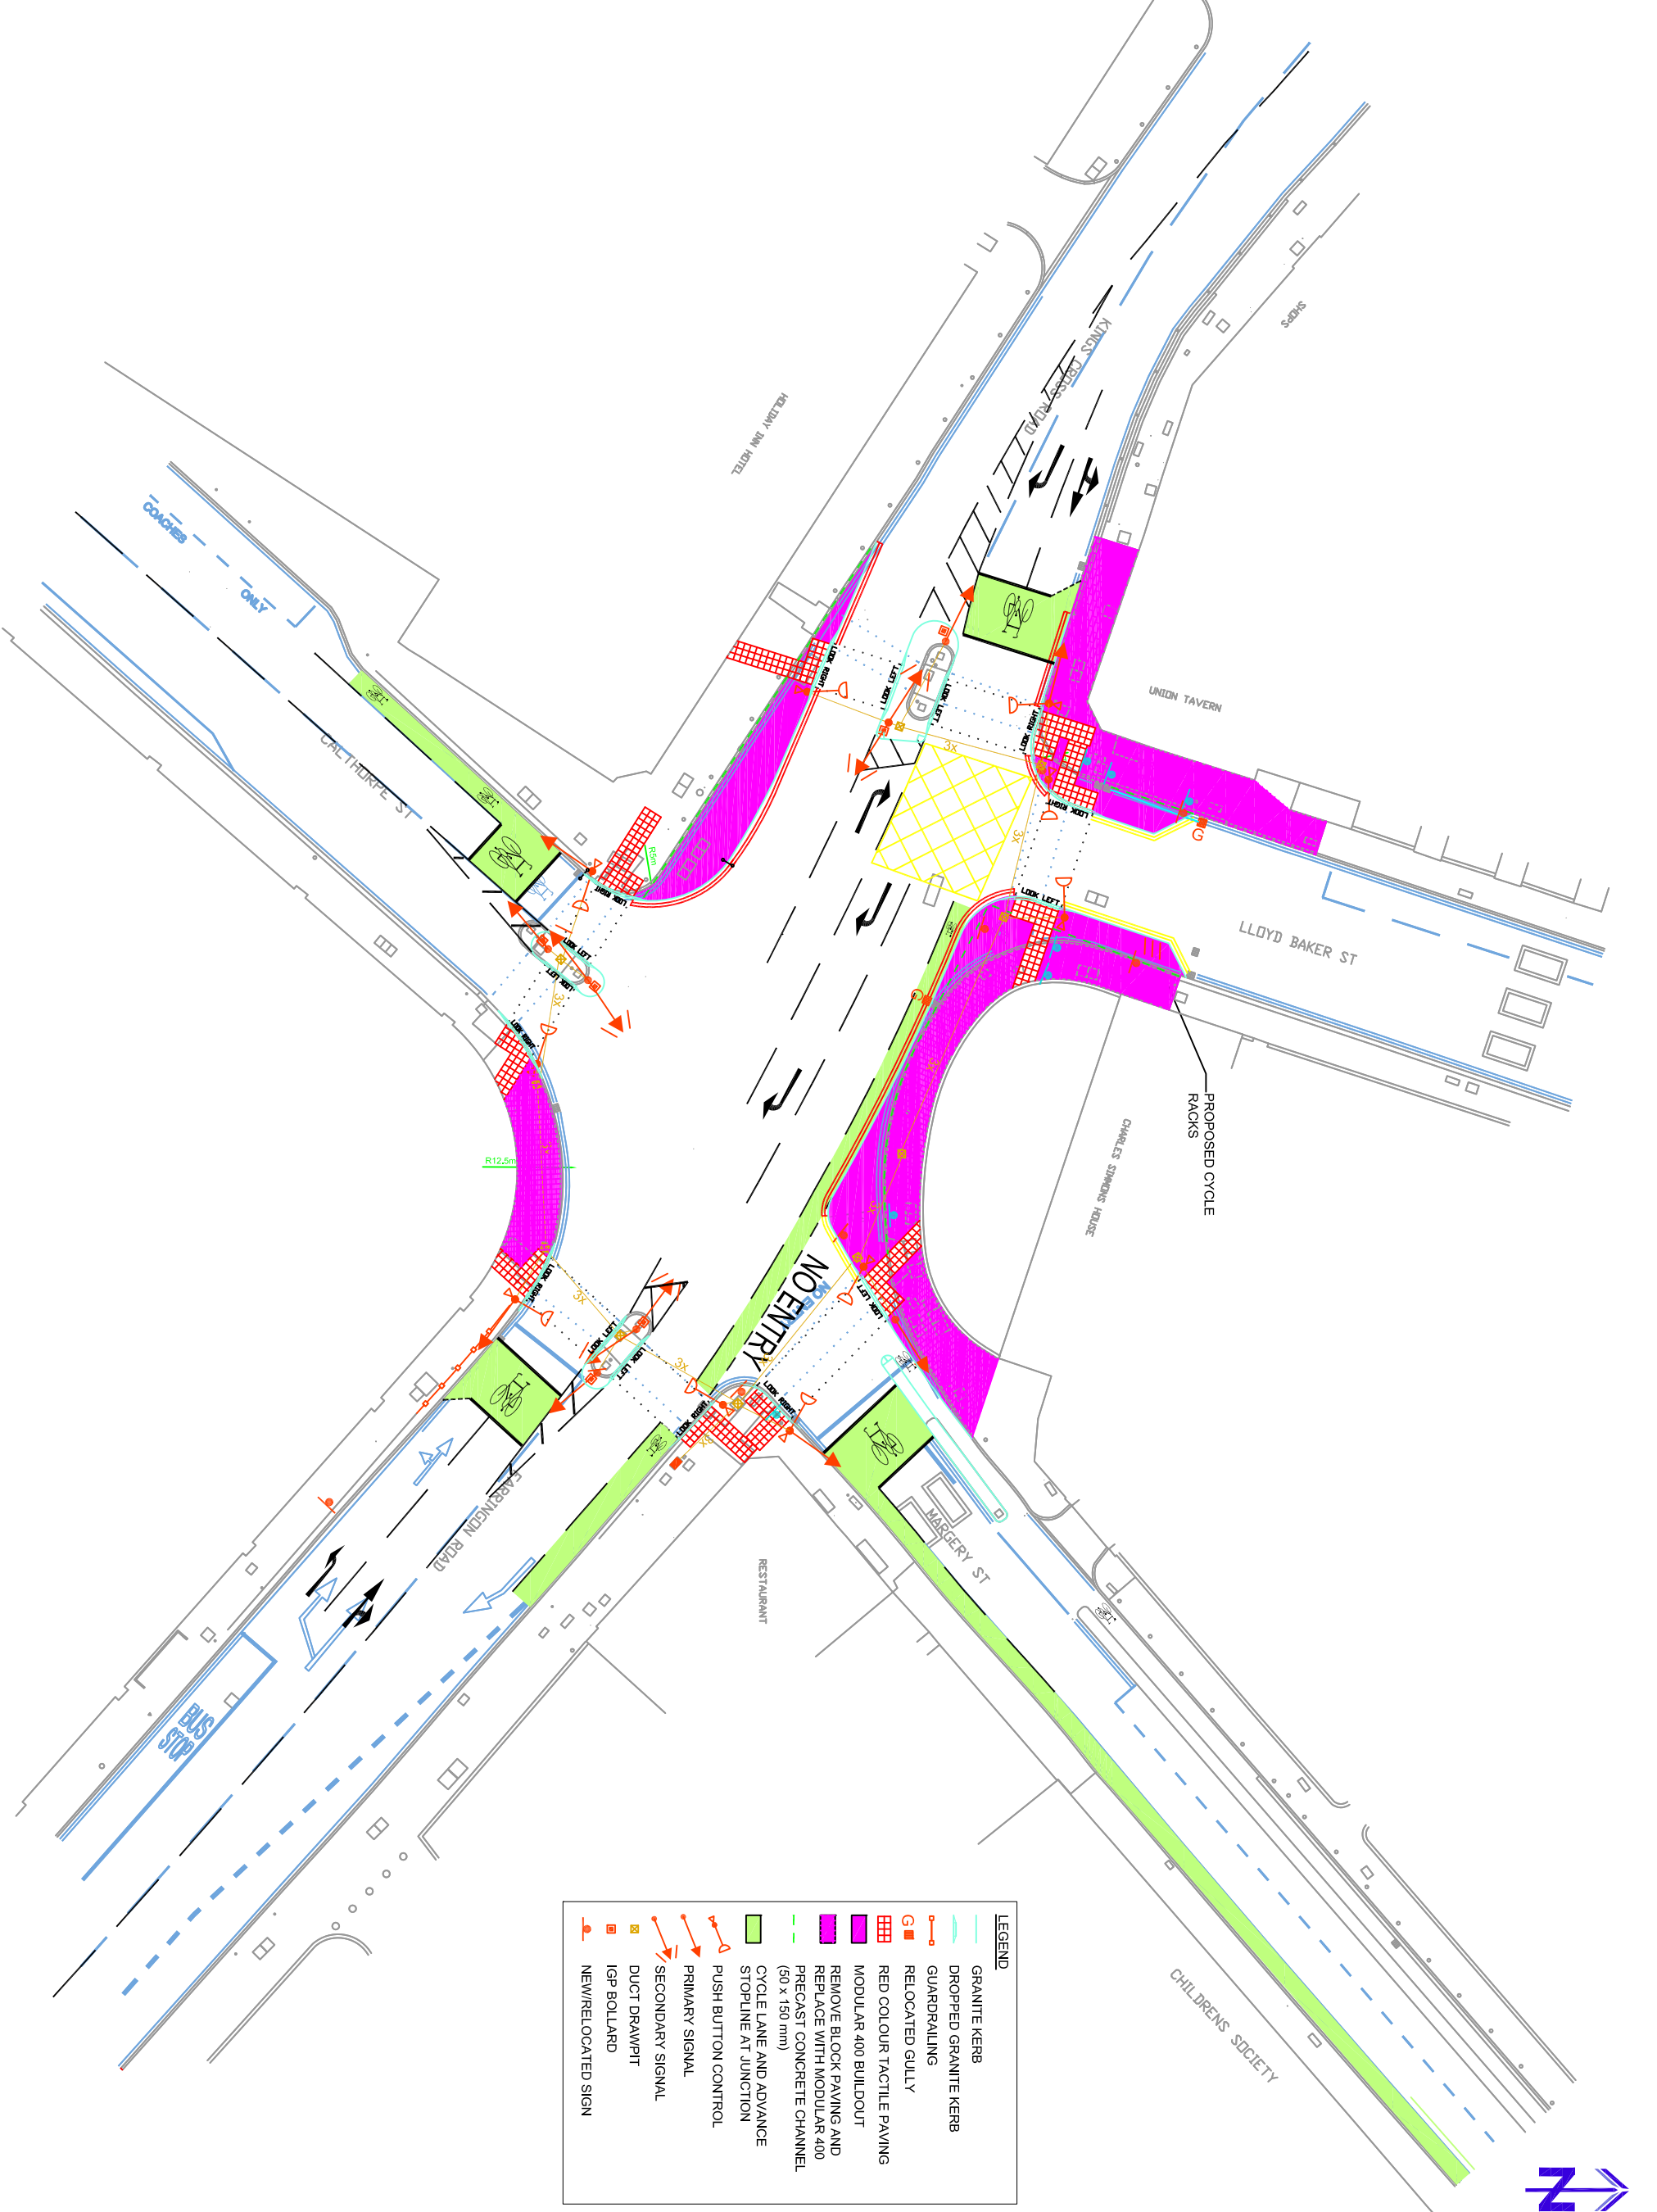

LEGEND	
	GRANITE KERB
	DROPPED GRANITE KERB
	GUARDRAILING
	RELOCATED GULLY
	RED COLOUR TACTILE PAVING
	MODULAR 400 BUILDOUT
	REMOVE BLOCK PAVING AND REPLACE WITH MODULAR 400
	PRECAST CONCRETE CHANNEL (60 x 150 mm)
	CYCLE LANE AND ADVANCE STOPLINE AT JUNCTION
	PUSH BUTTON CONTROL
	PRIMARY SIGNAL
	SECONDARY SIGNAL
	DUCT DRAUGHT
	IGP BOLLARD
	NEW/RELOCATED SIGN



- NOTES**
1. ALL DIMENSIONS ARE IN MILLIMETRES.
 2. IT IS THE CONTRACTOR'S RESPONSIBILITY TO CHECK AND VERIFY THE LOCATION OF UNDERGROUND SERVICES PRIOR TO EXCAVATION.
 3. THE DRAWING SHALL BE READ IN CONJUNCTION WITH THE FOLLOWING DESIGN DRAWINGS:
 - 9193107003 - SITE SETTING OUT
 - 9193107004 - SIGNS & ROADMARKINGS
 - 9193107005 - DUCTING & DRAINAGE LAYOUT
 4. THIS DRAWING SHALL BE READ IN CONJUNCTION WITH THE FOLLOWING STANDARD DETAIL DRAWINGS:
 - CRSD1101 - ON SITE INFORMATION BOARD
 - CRSD1102 - CONCRETE DETAIL STATEMENT
 - CRSD1103 - FLEXIBLE PAVING CONSTRUCTION
 - CRSD1104 - SPEED CUSHIONS
 - CRSD1105 - KERBS & FLOODLIGHTING DETAILS
 - CRSD1106 - DROPPED KERB DETAILS
 - CRSD1107 - FOOTWAY CONSTRUCTION
 - CRSD1108 - FOOTWAY CONSTRUCTION
 - CRSD1203 - BASE ILLUMINATED BOLLARD
 5. ALL GUARDRAILING, ILLUMINATED AND METAL BOLLARDS, RELOCATED WHERE AFFECTED AND AS DIRECTED BY THE ENGINEER.
 6. ALL SIGN POSTS SHALL BE CONSTRUCTED TO TYPE A REFER TO DRAWING CRSD1104) AND TYPE SLAVOUT REFER TO DRAWING CRSD1104). ALL SIGN POSTS SHALL BE ADJUSTED AS REQUIRED TO NEW LEVEL WHERE CONFLICT WITH WORK.
 7. ALL SIGNS BOXES WITHIN CROSSING AREA SHOULD HAVE RECESS COVER.

Client
 TRANSPORT FOR LONDON
 STREET MANAGEMENT

Job Title
 FARRINGDON ROAD JUNCTION
 WITH CALTHORPE STREET

Drawing Title
 GENERAL LAYOUT

Rev	Date	Amendment	Des.	Drn.

Nonsucha House
 45 Norfolk Hill Gate
 London
 W11 3PB
 T: 020 7299 7000
 F: 020 7299 0906
 www.ductman.co.uk

DUCTMAN

Disc	Disc	Check	Appr	Job No.	First Issue/Scale

Job No: 91931/OT/001